


\\BOOKWORLD\Public\CIA-Projects\Folder\CIA-Projects\Folder\Chestnut Marlboro\10-5-16 for PB\0305 Chestnut Marlborough sites 10-5-16.dwg, 10/5/2016 4:29:22 PM, DWG To PDF.pc3

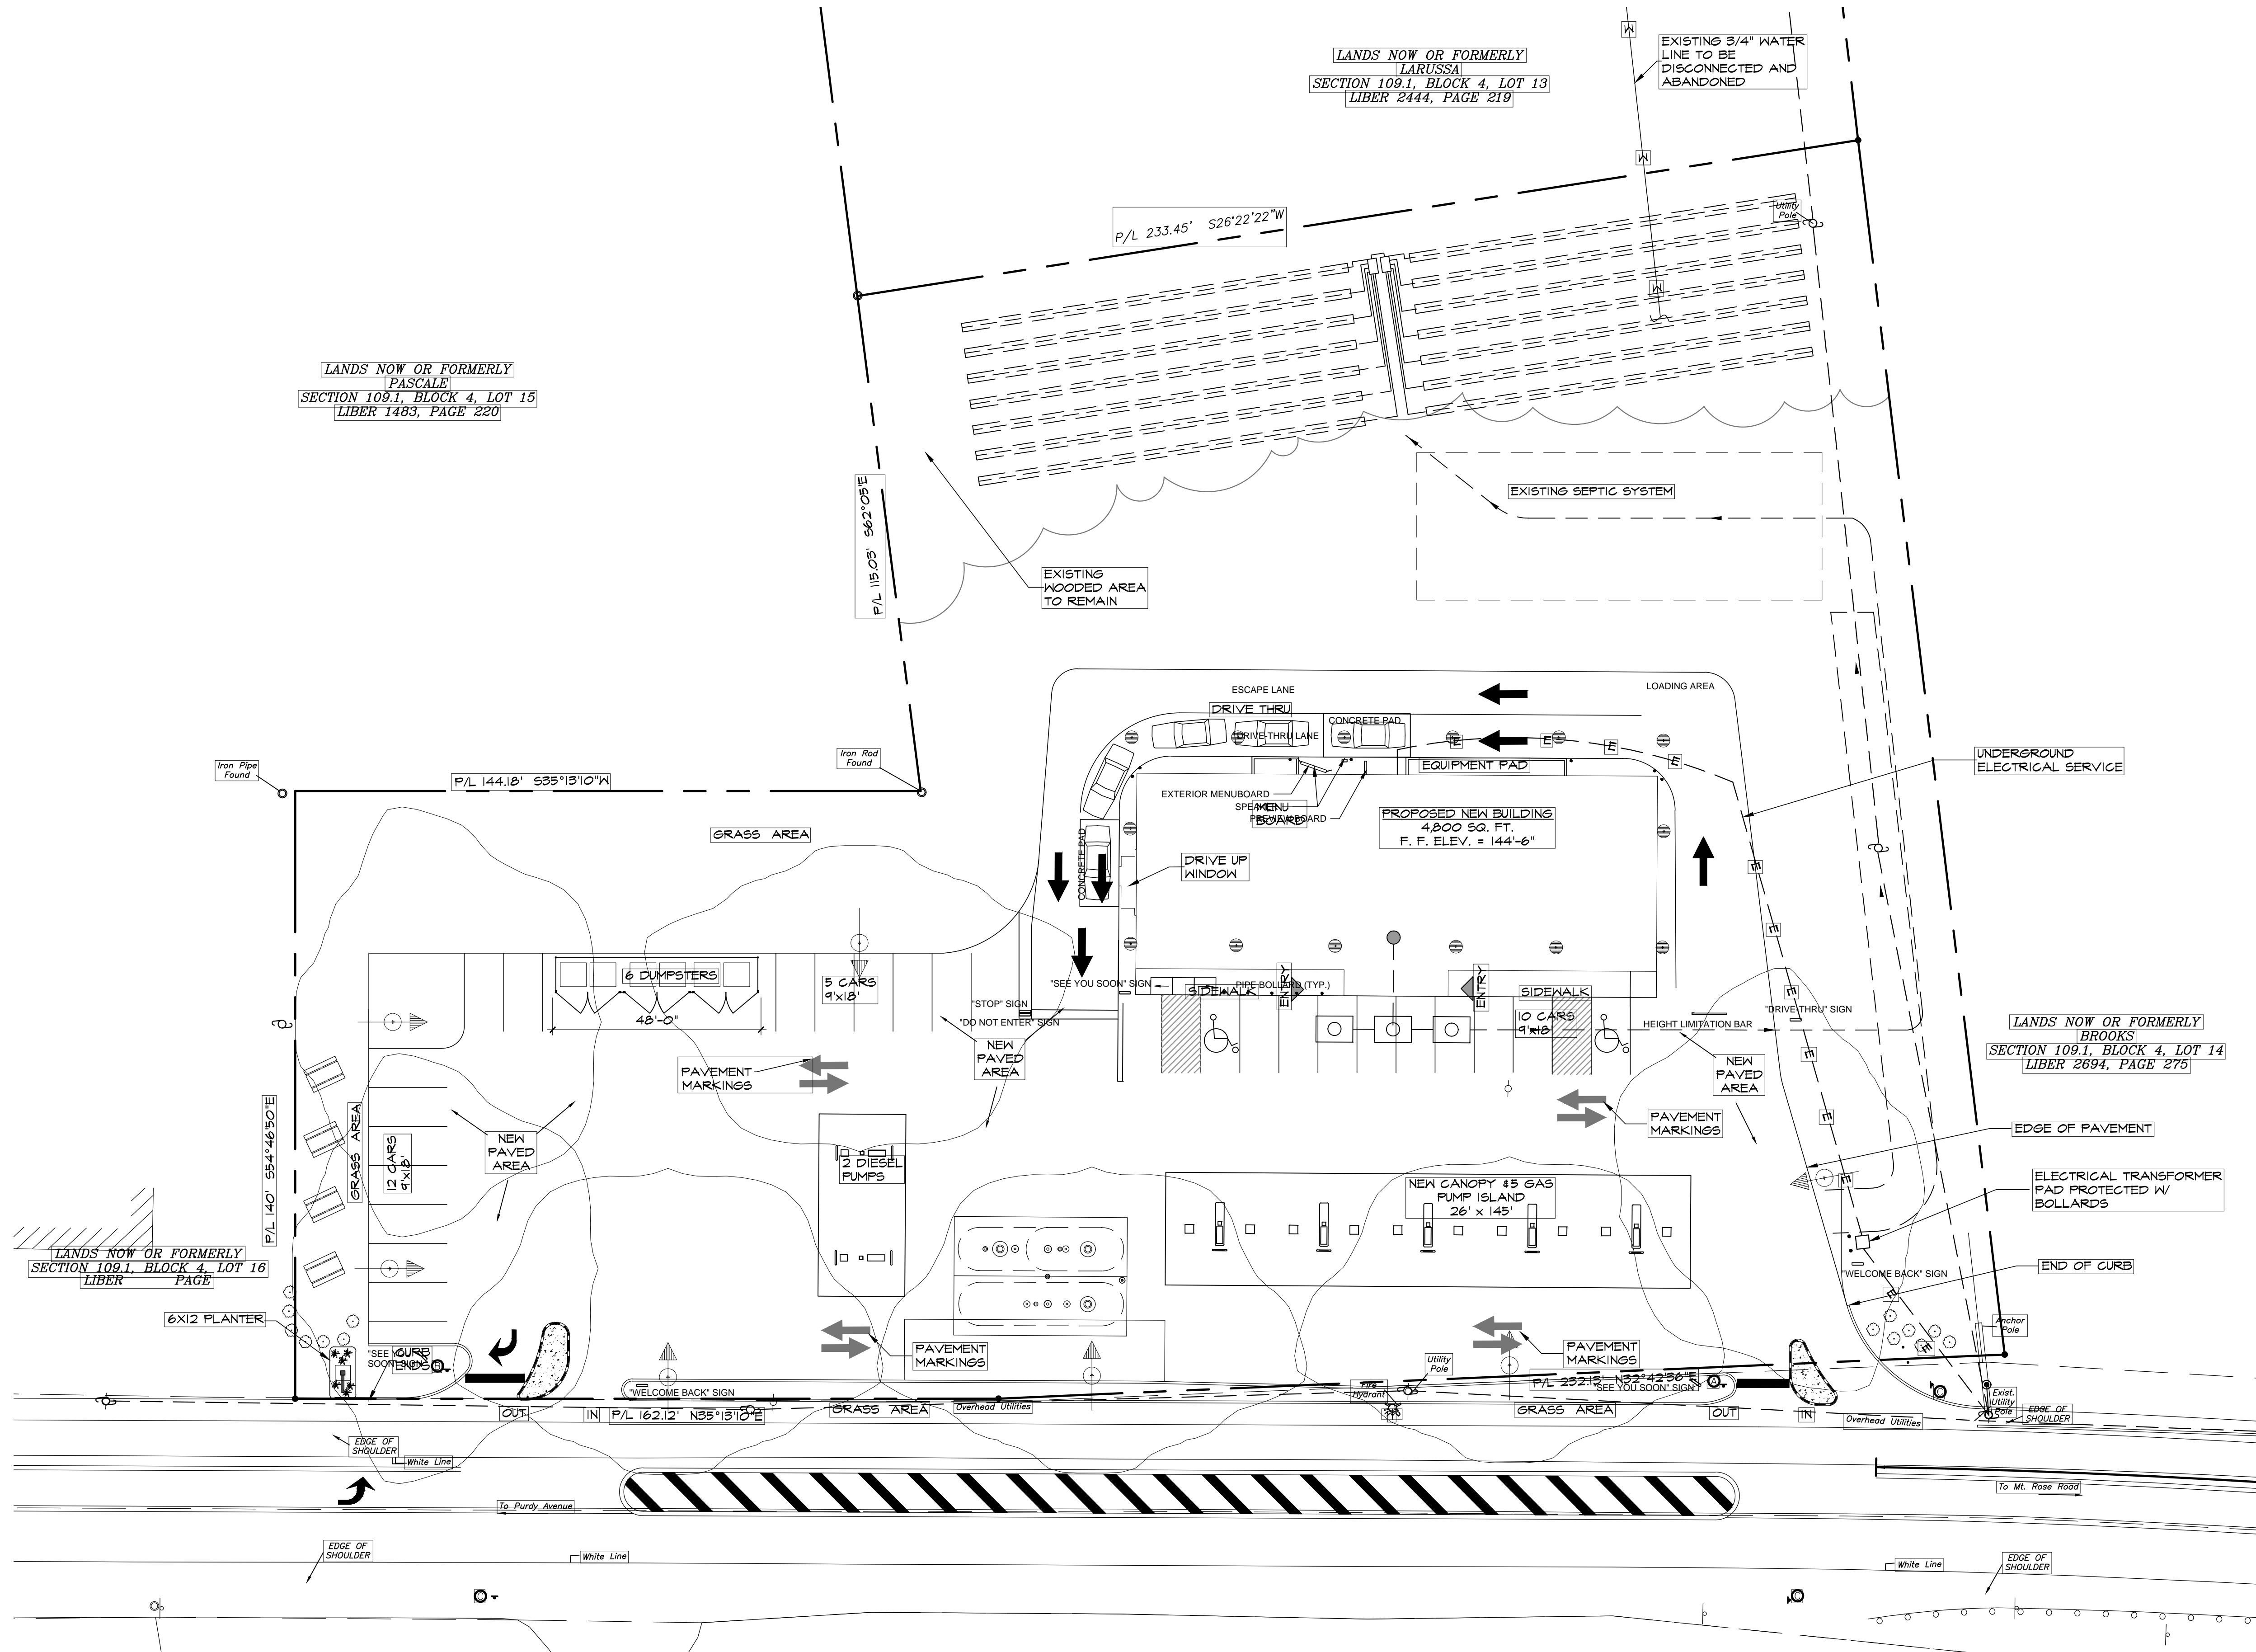

LIGHTING PLAN
 SP4 SCALE: 1" = 20'-0"



| No. | Date | Description |
|-----|----------|-------------------|
| 1 | 2-16-15 | GENERAL REVISIONS |
| 2 | 4-2-15 | GENERAL REVISIONS |
| 3 | 4-7-15 | GENERAL REVISIONS |
| 4 | 5-26-15 | QUEUE |
| 5 | 6-15-15 | PER MHE COMMENTS |
| 6 | 10-24-15 | PER CPD COMMENTS |
| 7 | 10-31-15 | COORDINATION |
| 8 | 1-8-16 | DATA TABLE |
| 9 | 4-22-16 | COORDINATION |
| 10 | 4-24-16 | GENERAL REVISIONS |



| PROPOSED SITE PLAN FOR: | |
|---|--------------------|
| CHESTNUT MART OF MARLBOROUGH | |
| 1417 ROUTE 9W | MARLBOROUGH, NY |
| CIRO INTERRANTE ARCHITECT, P.C. | |
| 85 MARKET STREET Poughkeepsie, New York 12601 | |
| (845) 473-1512 Office | (845) 473-1525 Fax |

| | |
|--------------|--------------|
| Project No: | 03-05 |
| DRAWN BY: | BM/MW/GG |
| ISSUED DATE: | 5 MARCH 2015 |

SHEET NO.
SP4
 SITE PLAN